


- Notes:
- Optional venturi flow sensor and magnehelic flow indicators with lo range of 0-15 scfm and hi range of 0-40 scfm available

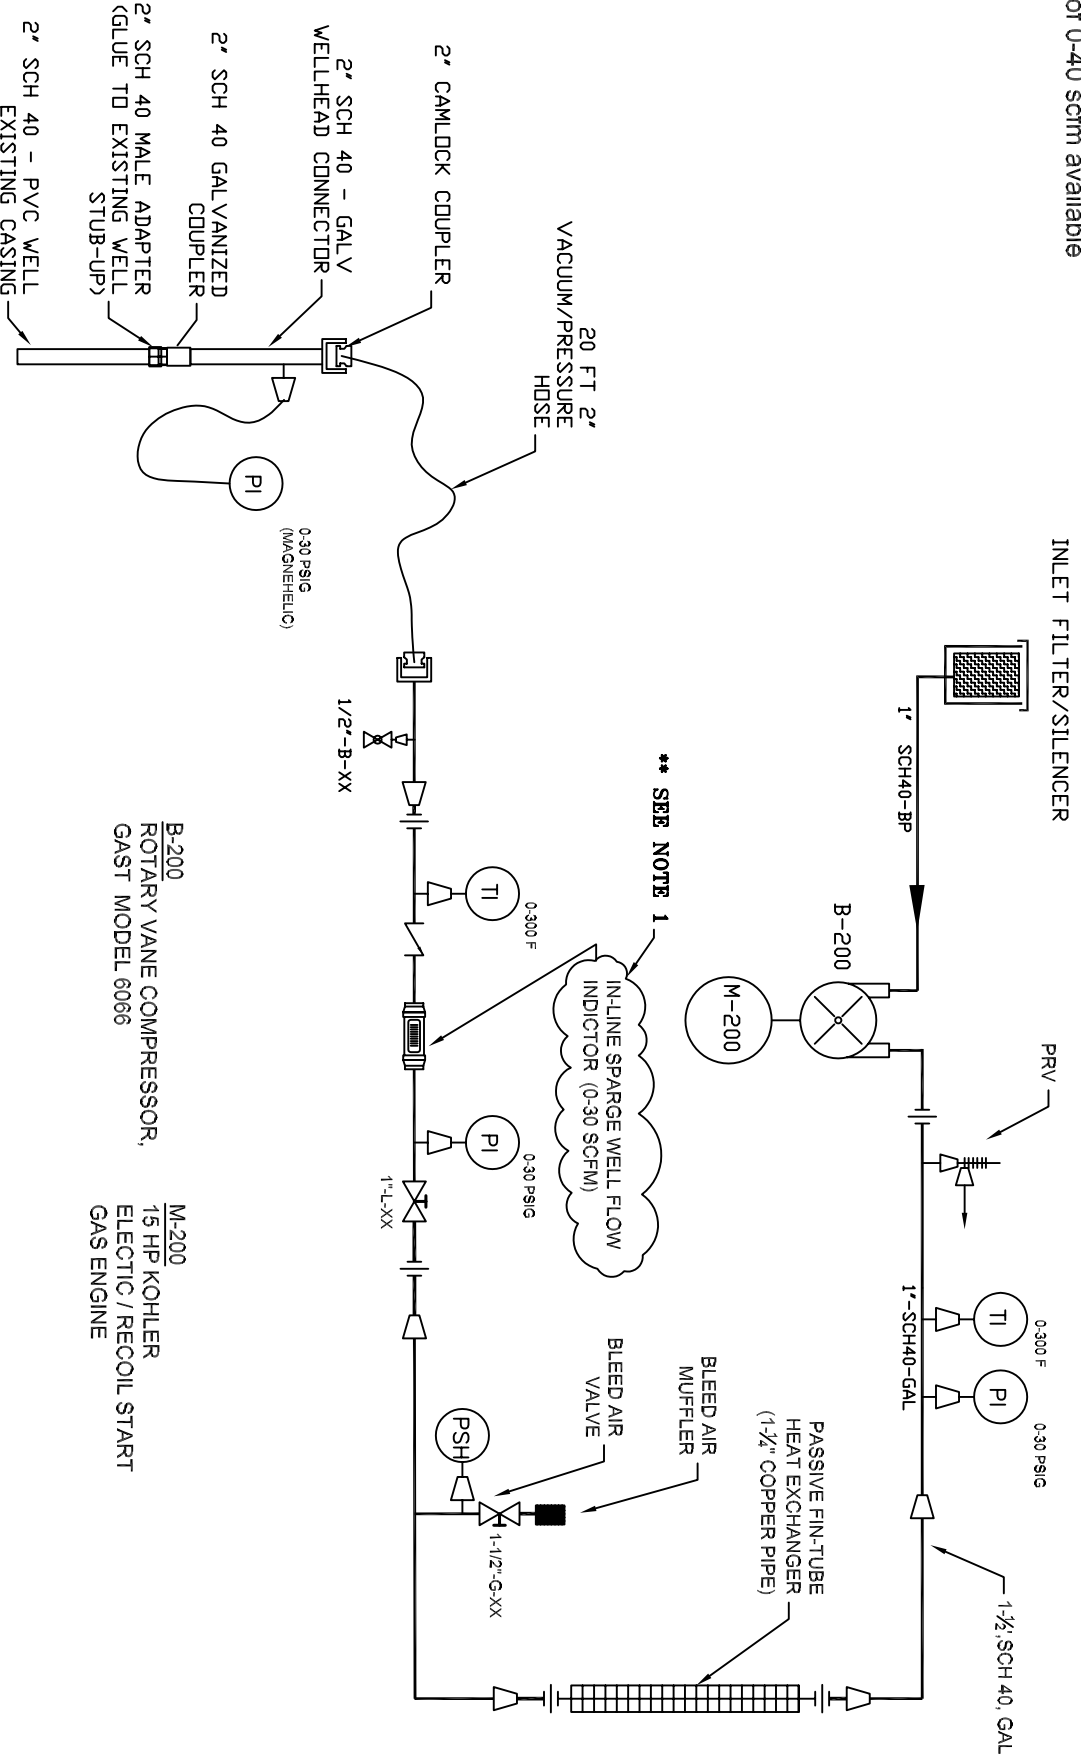

B-200
 ROTARY VANE COMPRESSOR,
 GAST MODEL 6066

M-200
 15 HP KOHLER
 ELECTRIC / RECOIL START
 GAS ENGINE

** SEE NOTE 1

***INFORMATION PRESENTED ON THESE DRAWINGS IS CONSIDERED PROPRIETARY INFORMATION OF PROCESS TECHNOLOGY SUPPORT, LLC. AND IS INTENDED SOLELY FOR USE BY PTS'S CLIENT FOR PROJECT INDICATED IN TITLE BLOCK. DUPLICATION OF THESE DRAWINGS FOR ANY OTHER USES WITHOUT WRITTEN AUTHORIZATION IS PROHIBITED.

DRAWN BY:	DATE:	DESCRIP:
TJS	2/22/05	AS-BUILT

Process Technology Support, LLC
 Trailer Mounted SVE / Air Sparge Pilot Test System

ACAD Title	DWG NO.:
PTS pilot skid trailer_PTD.DWG	P2

**PILOT SKID AIR SPARGE SYSTEM
 PROCESS FLOW DIAGRAM**