



 




NORRLIN LIBRARY

LEGEND

	Deciduous Tree
	Evergreen Tree
	Tree to be Removed
	Concrete Benches
	Existing Inlet

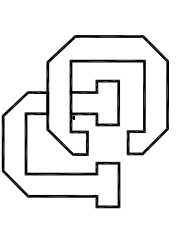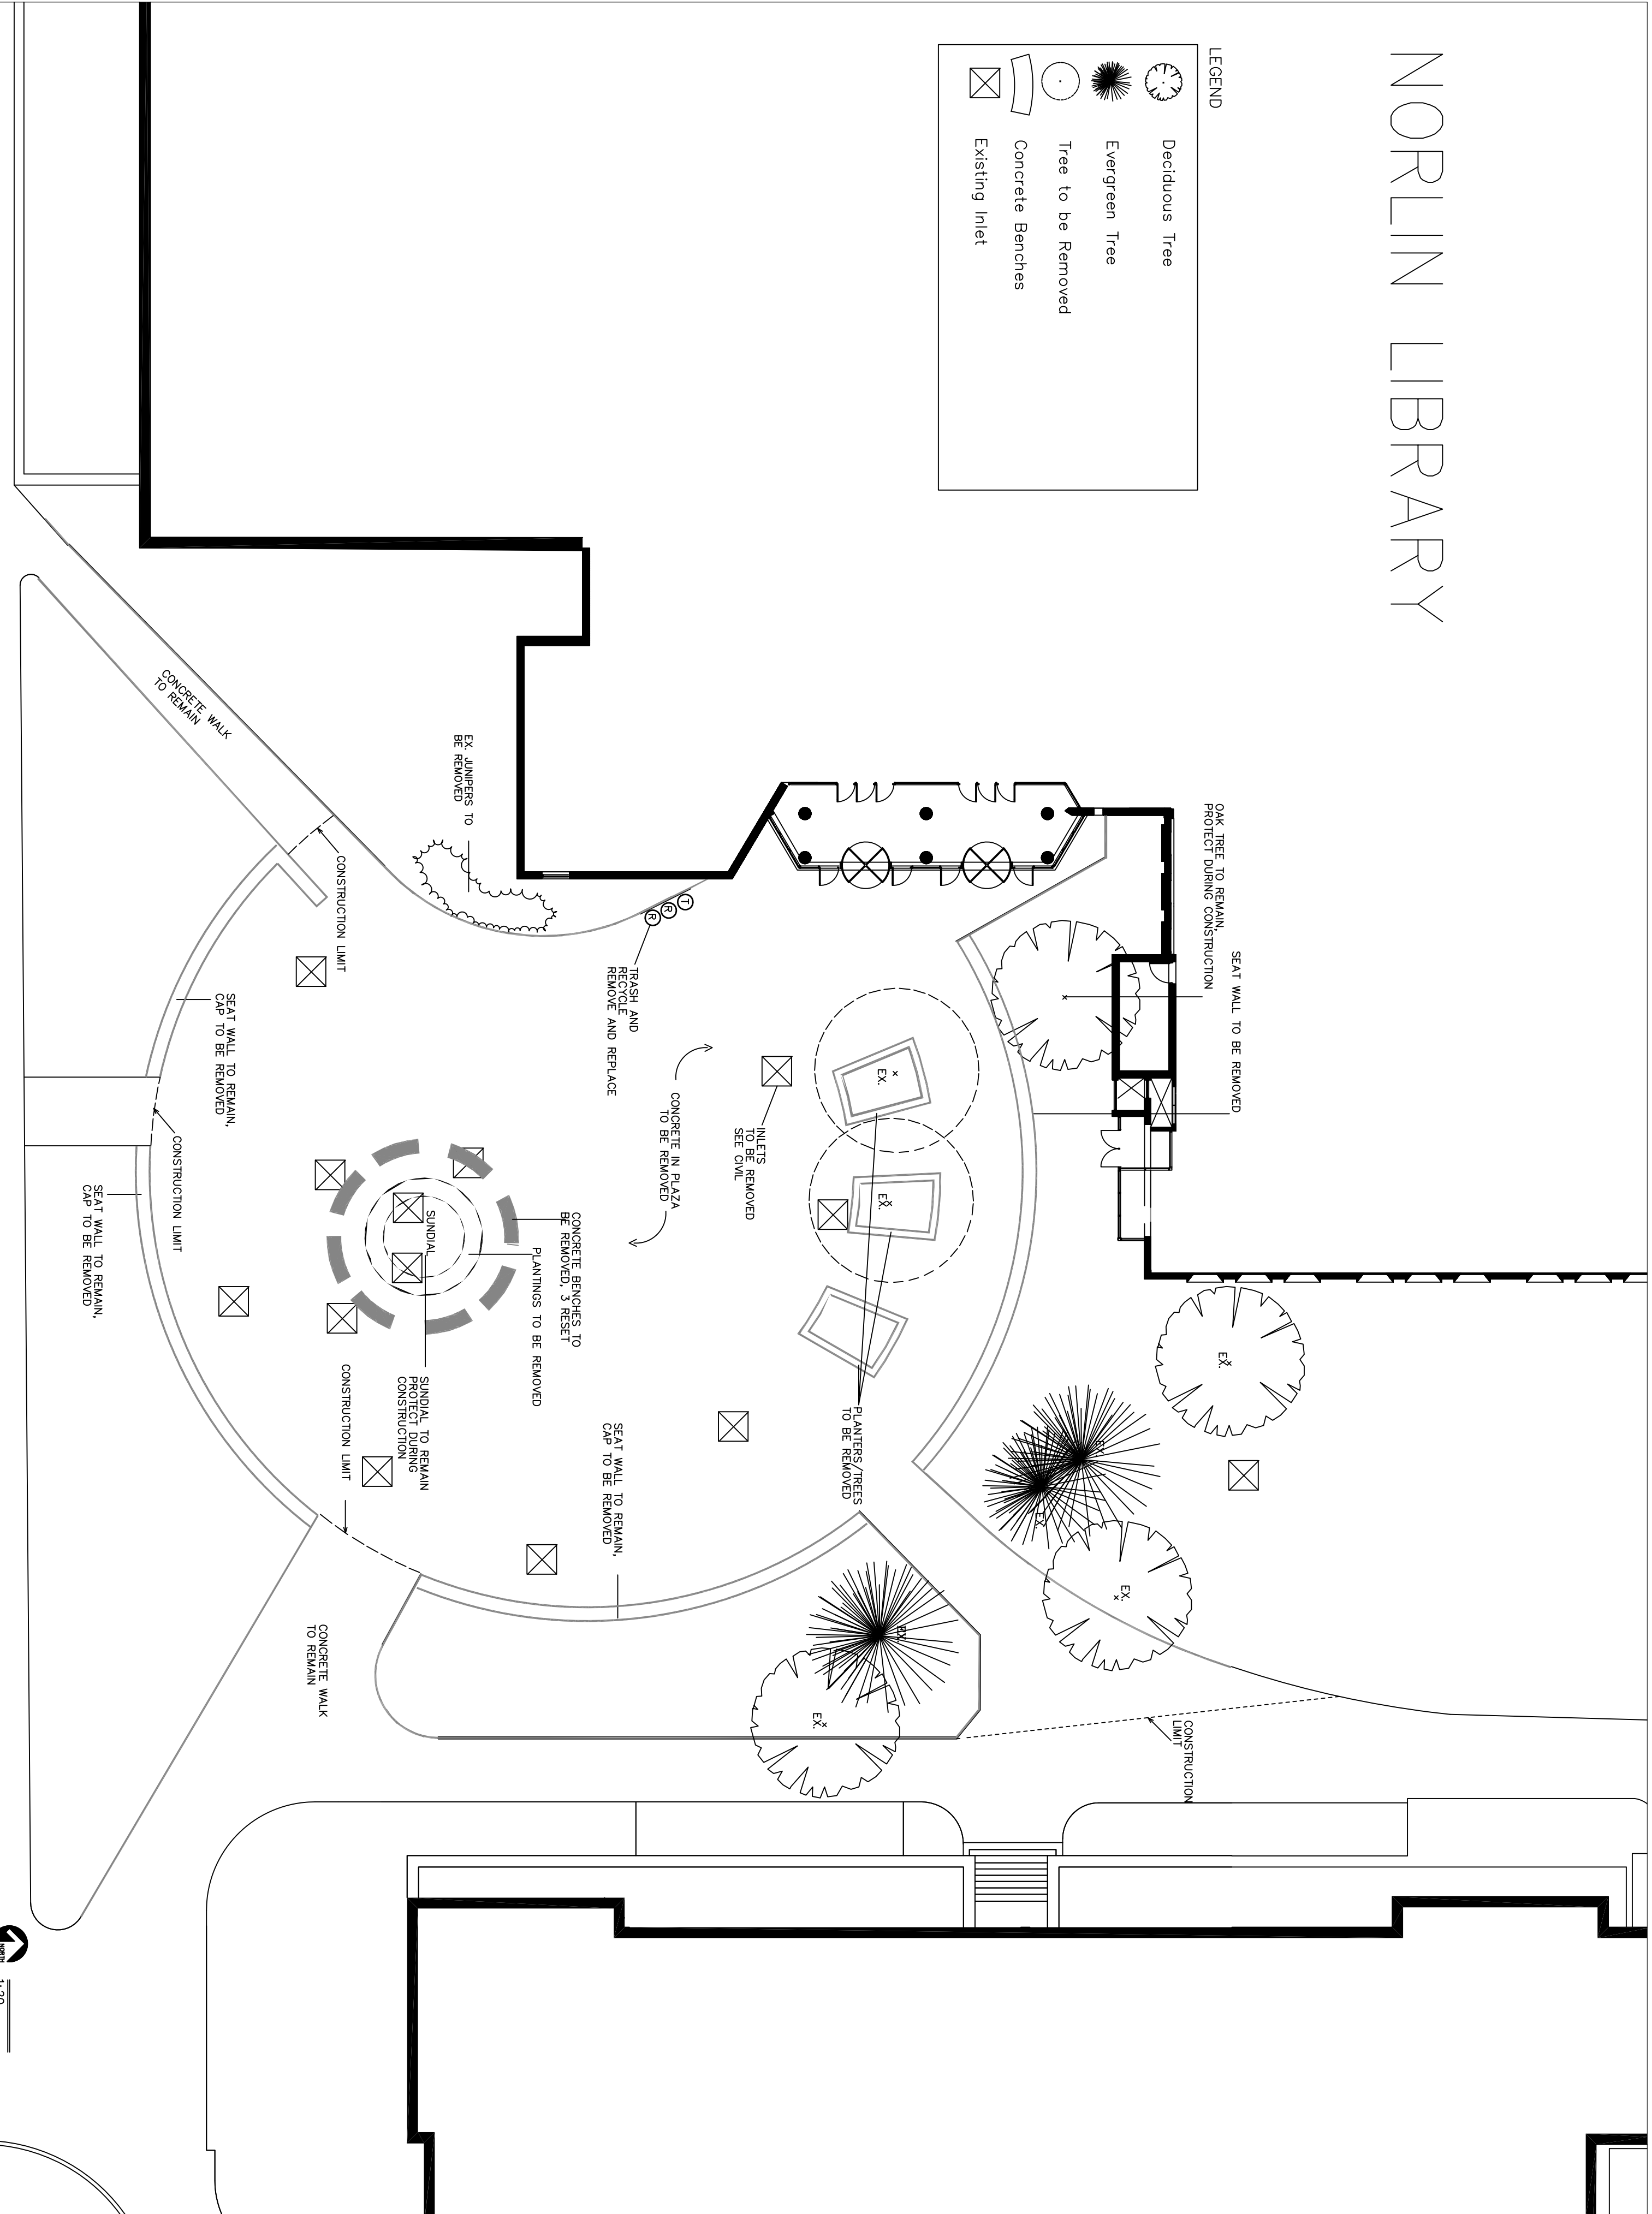

University of Colorado
 1540 30th Street
 Building RI2
 Boulder, Colorado
 90309-0053
 Campus Box 453
 (303) 492-3500
 Fax: (303) 492-2921

University of Colorado
 Boulder Colorado
 Norlin Library - Sundial Plaza

Revisions:

Drawn by: RR

Checked: --

 
Approved:

Date: 02.03.2009

Sheet: - of -

WO #.



DEM PLAN



NORLIN LIBRARY

NOTES

1. PROTECT EXISTING SUNDIAL.
2. INTERACTIVE FOUNTAIN, SEE SHEET ----.
3. TURF SET IN GEOBLOCK SYSTEM. SEE DETAIL. (S)
4. RELOCATE CONCRETE BENCHES.
5. AQUA BRIC PAVERS, HERRINGBONE PATTERN. SEE DETAIL. (S)
6. AQUA BRIC PAVERS, RUNNING BOND PATTERN.
7. FACE EXISTING SEAT WALL WITH SANDSTONE VENEER/NEW PRECAST CAP.
8. NEW SEAT WALL.
9. CAMPUS STANDARD TABLE. HEIGHTS/CONFIGURATIONS MIXED.
10. NEW CAMPUS STANDARD LIGHT POLE. ELECTRICAL PLAN.
11. NEW CAMPUS STANDARD BOLLARD.
12. 60" D CAMPUS STANDARD TREE GRATE (TYP.) NEENAH FOUNDRY METROPOLITAN COLLECTION. SEE DETAIL. (S)
13. 3' x 3' SANDSTONE PANEL WITH QUOTE. SEE DETAIL. (S)
14. EXISTING TREES--PROTECT DURING CONSTRUCTION.
15. NEW TREES. SEE SHEET ----.
16. TRASH/RECYCLE REMOVE, REPLACE.

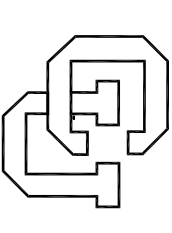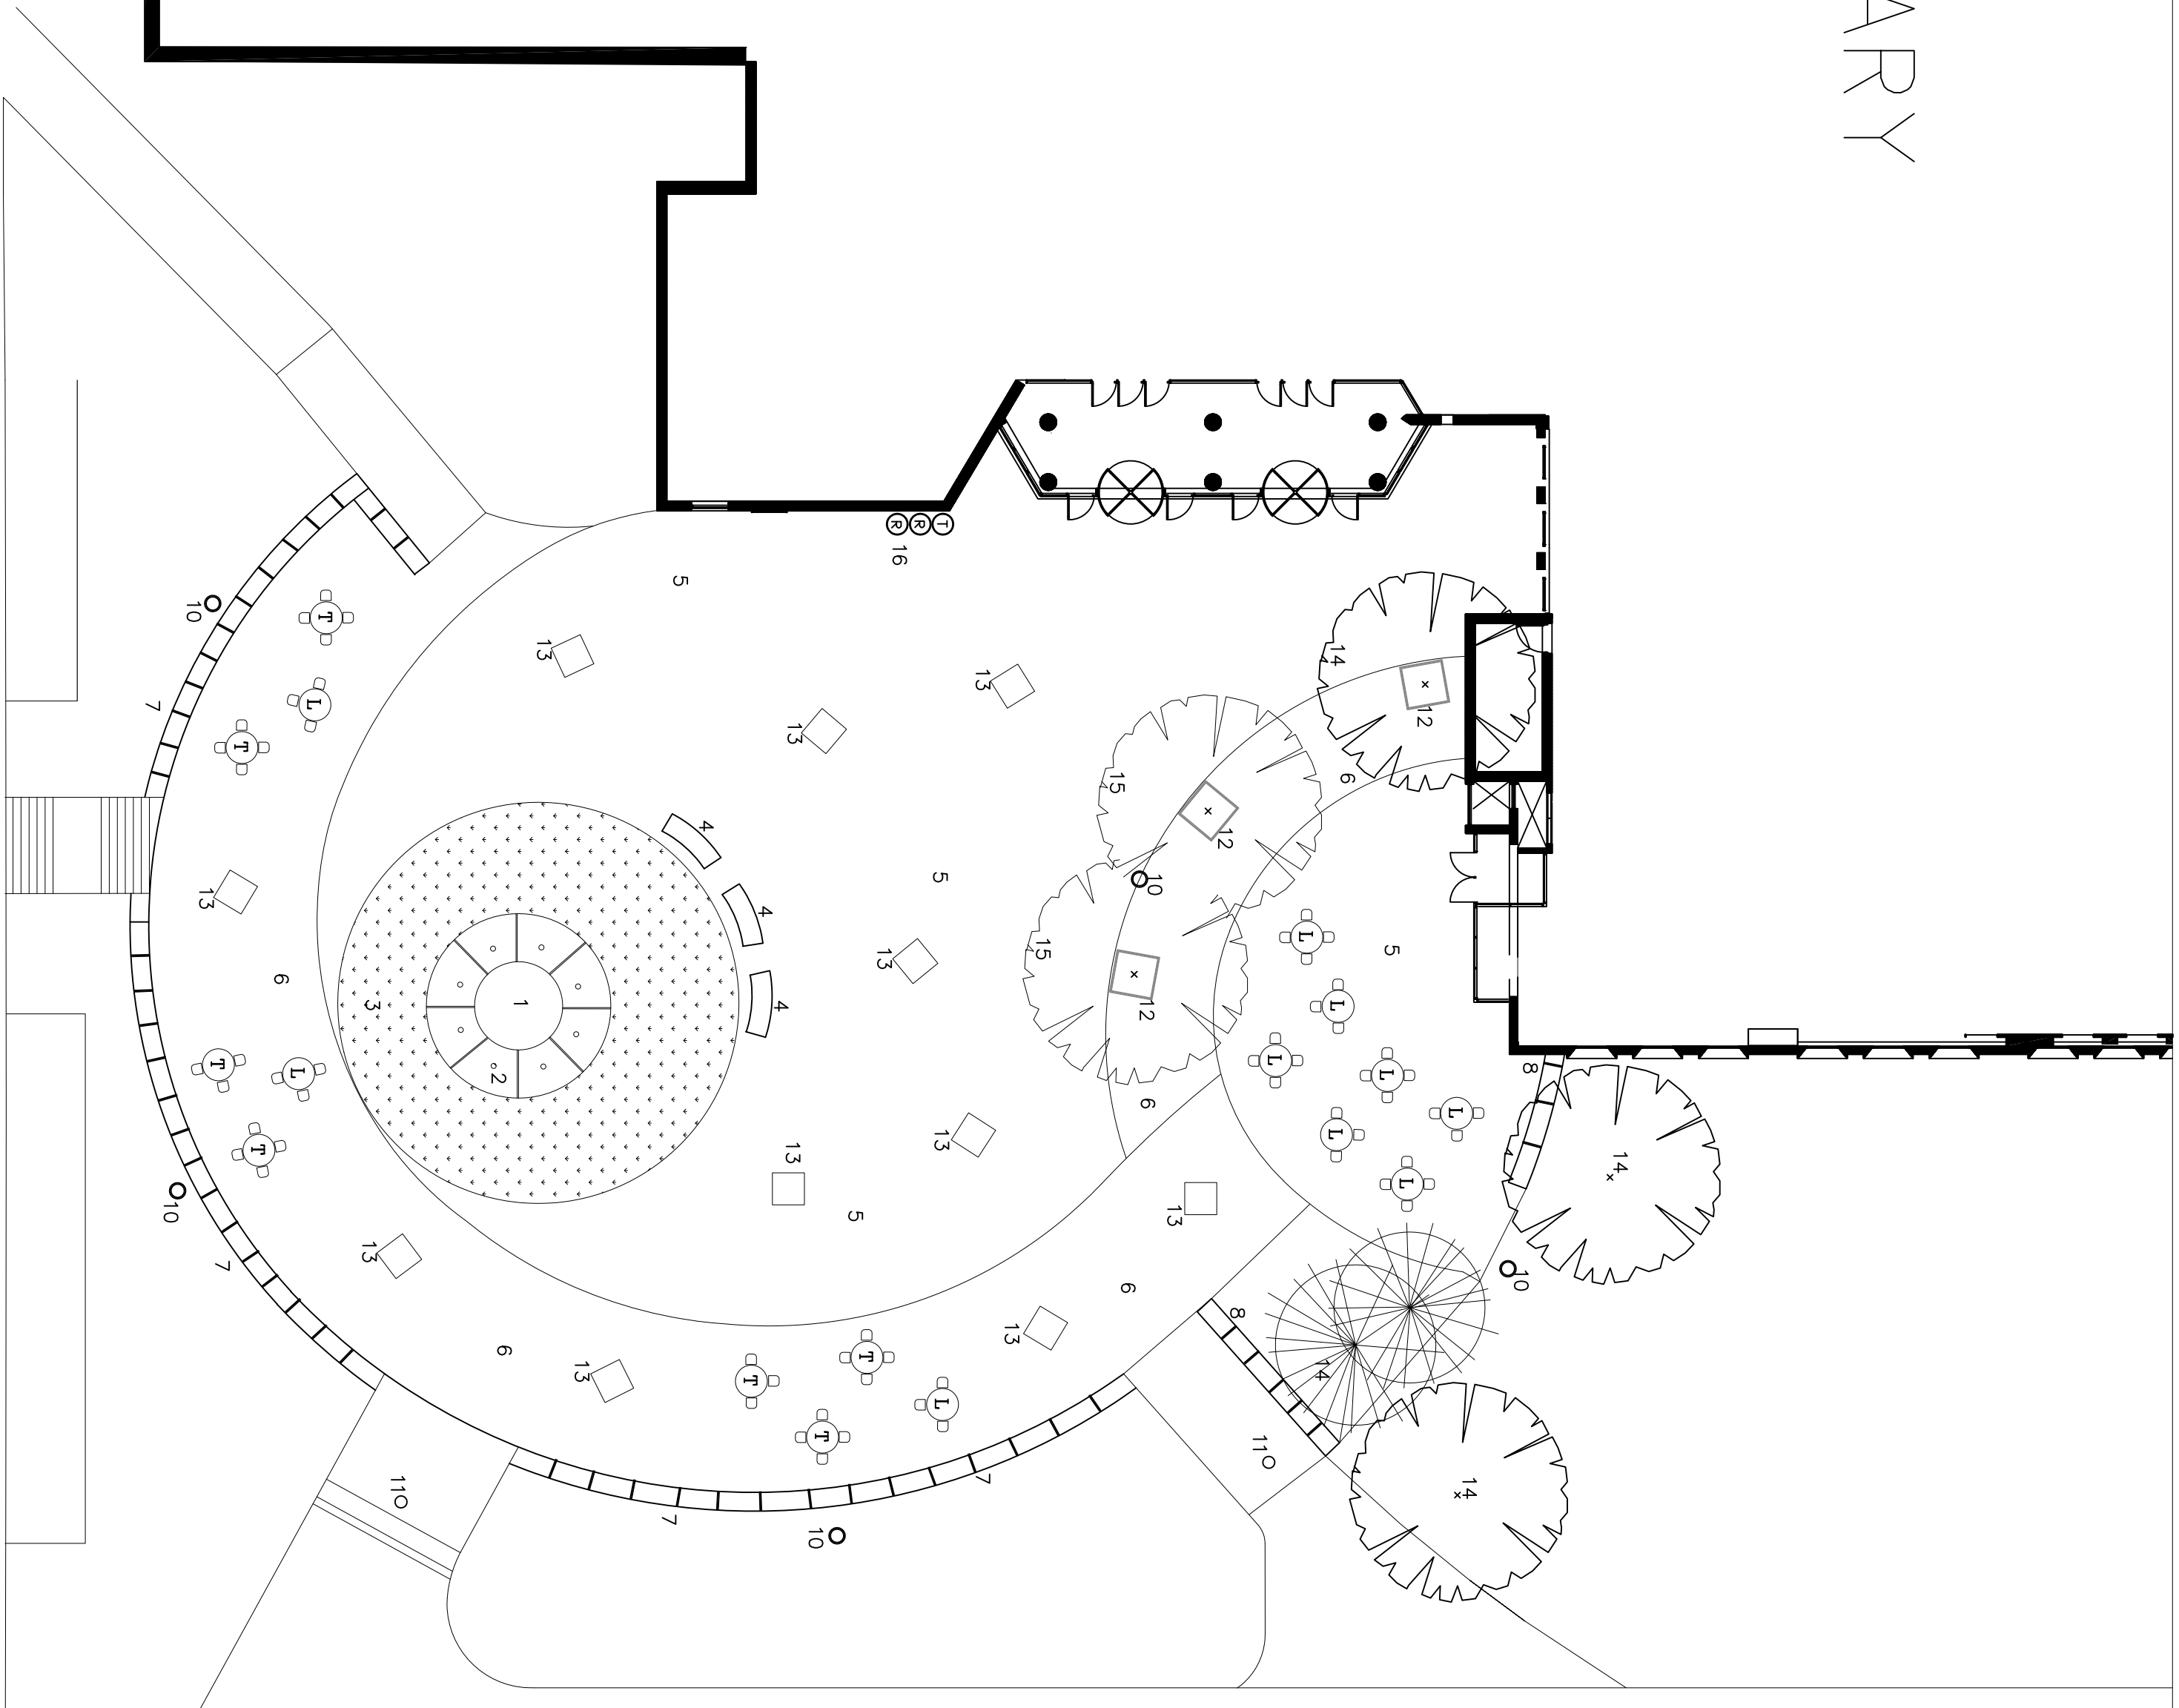

University of Colorado
 1540 30th Street
 Building RL2
 Boulder, Colorado
 90309-0053
 Campus Box 453
 (303) 492-3500
 Fax: (303) 492-2921

University of Colorado
 Boulder Colorado
 Norlin Library - Sundial Plaza

Revisions:

Drawn by: RR

Checked: --

Approved:

Date: 02.03.2009

Sheet: - of -

WO #.

SITE PLAN

L-2





NORLIN LIBRARY

LEGEND

SYMBOL		
	ELECTRIC CONTROL VALVE	
	RAINBIRD 1804 WITH 8 VAN	
	RAINBIRD 1804 WITH 8 VAN FOR INTERLOCK TURF	SIZE AS NOTED ON PRINT
	PVC SCH-40 LATERAL PIPE	MAIN ON PRINT IS NOT TO SCALE (FIELD VERIFY)
	MAIN LINE EXISTING	
	POLY LATERAL FOR TURF AREAS	

*HEADS TO BE PLACED ON FUNNY SWING JOINTS IN TURF AREAS.
 -DOUBLE CLAMP ALL POLY JOINTS & FITTINGS INSIDE CIRCLE & CUT GEOBLOCK TO ACCOMMODATE HEADS & MAINTENANCE.

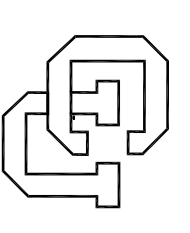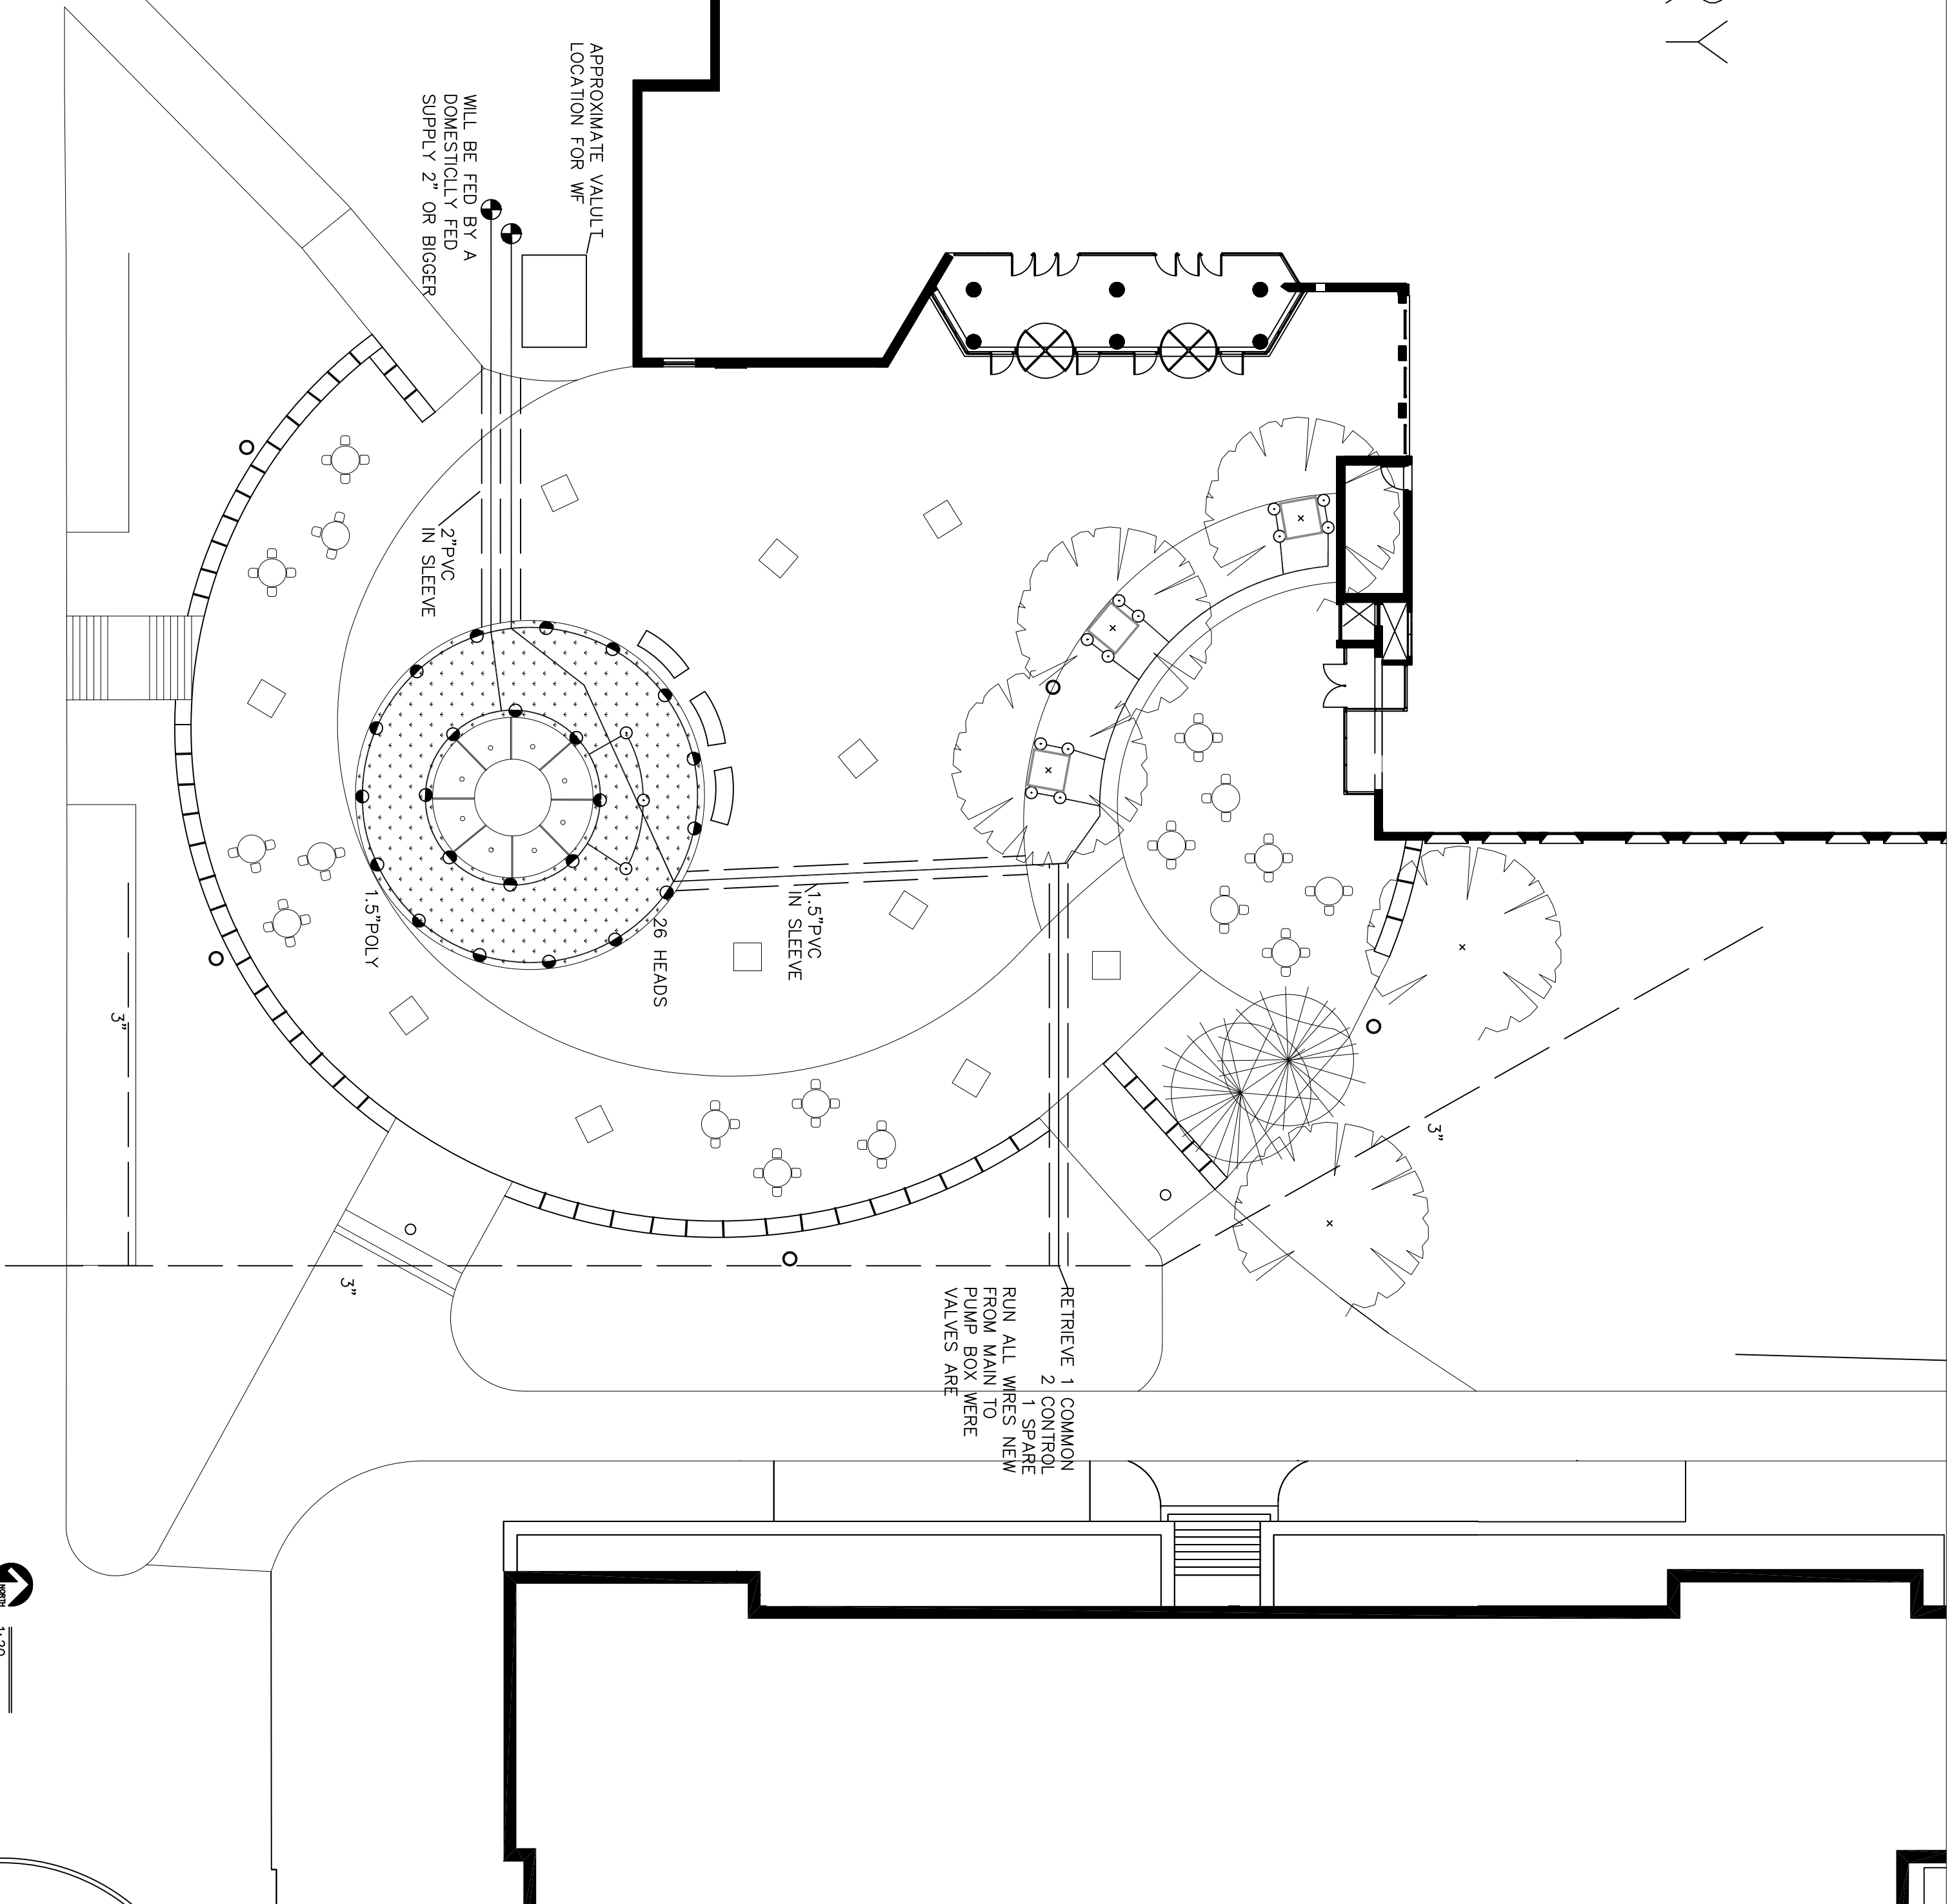

University of Colorado
 1540 30th Street
 Boulder, CO 80509
 90309-0053
 Campus Box 453
 (303) 492-3500
 Fax: (303) 492-2921

University of Colorado
 Boulder Colorado
 Norlin Library - Sundial Plaza

Revisions:

Drawn by: RR

Checked: --

Approved:

Date: 02.03.2009

Sheet: - of -

WO #.

IRRIGATION PLAN