



7.301-404-0311
 E: FRODO@CO.GOV
 NOTE: THIS DRAWING IS NOT TO BE USED
 FOR ANY OTHER PURPOSES WITHOUT
 WRITTEN PERMISSION

RESEARCH LAB NO 2

- Guarantee - EXP 3/31/28
- Albireo - EXP 11/30/26
- Vacant

- Not rentable
- Sun Const - EXP 11/30/28
- CIRES - EXP 4/30/27


- Century - EXP 10/31/26
- SSI - Exp. 8/31/27
- Facilities - EXP 11/30/28
- Lambda - EXP 9/30/27

- A&P - Exp - 7/31/27
- Paladin - EXP 3/31/28
- Legacy - EXP 9/30/26
- Design & const - MTM
- GH Phipps - EXP 1/12/27

RL2 Occupancy – 1st Floor




RL2 Occupancy – 2nd Floor

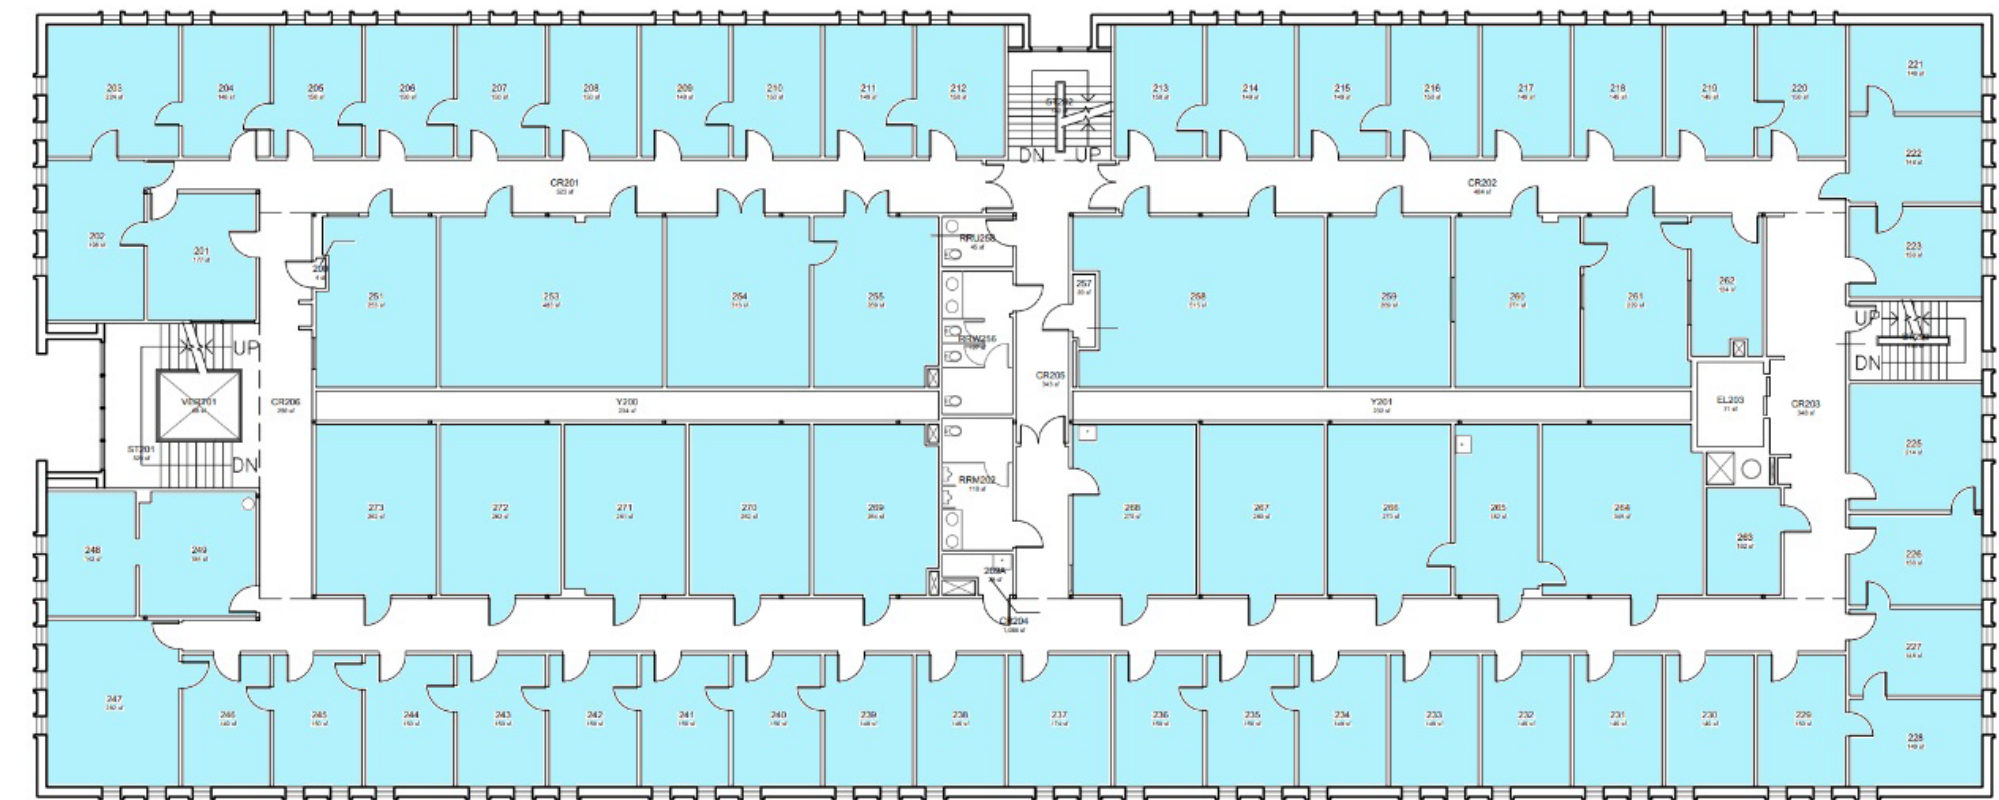

Colorado scument ent	P. 300-480-5211 E. FMCAD@CO.DRADD.EDU NOTE: THIS DRAWING IS NOT TO BE USED FOR DESIGN OR CONSTRUCTION WITHOUT VERIFICATION OF DIMENSIONS. PLEASE NOTIFY THE FMCAD OFFICE OF DISCREPANCIES.	RESEARCH LAB NO 2	 CIRES - Expires 12/31/28
		1540 30TH ST	
		SCALE: 1/16"=1'-0" WHEN PRINTED ON 11x17 SHEET	

RL2 OCCUPANCY – 3RD FLOOR

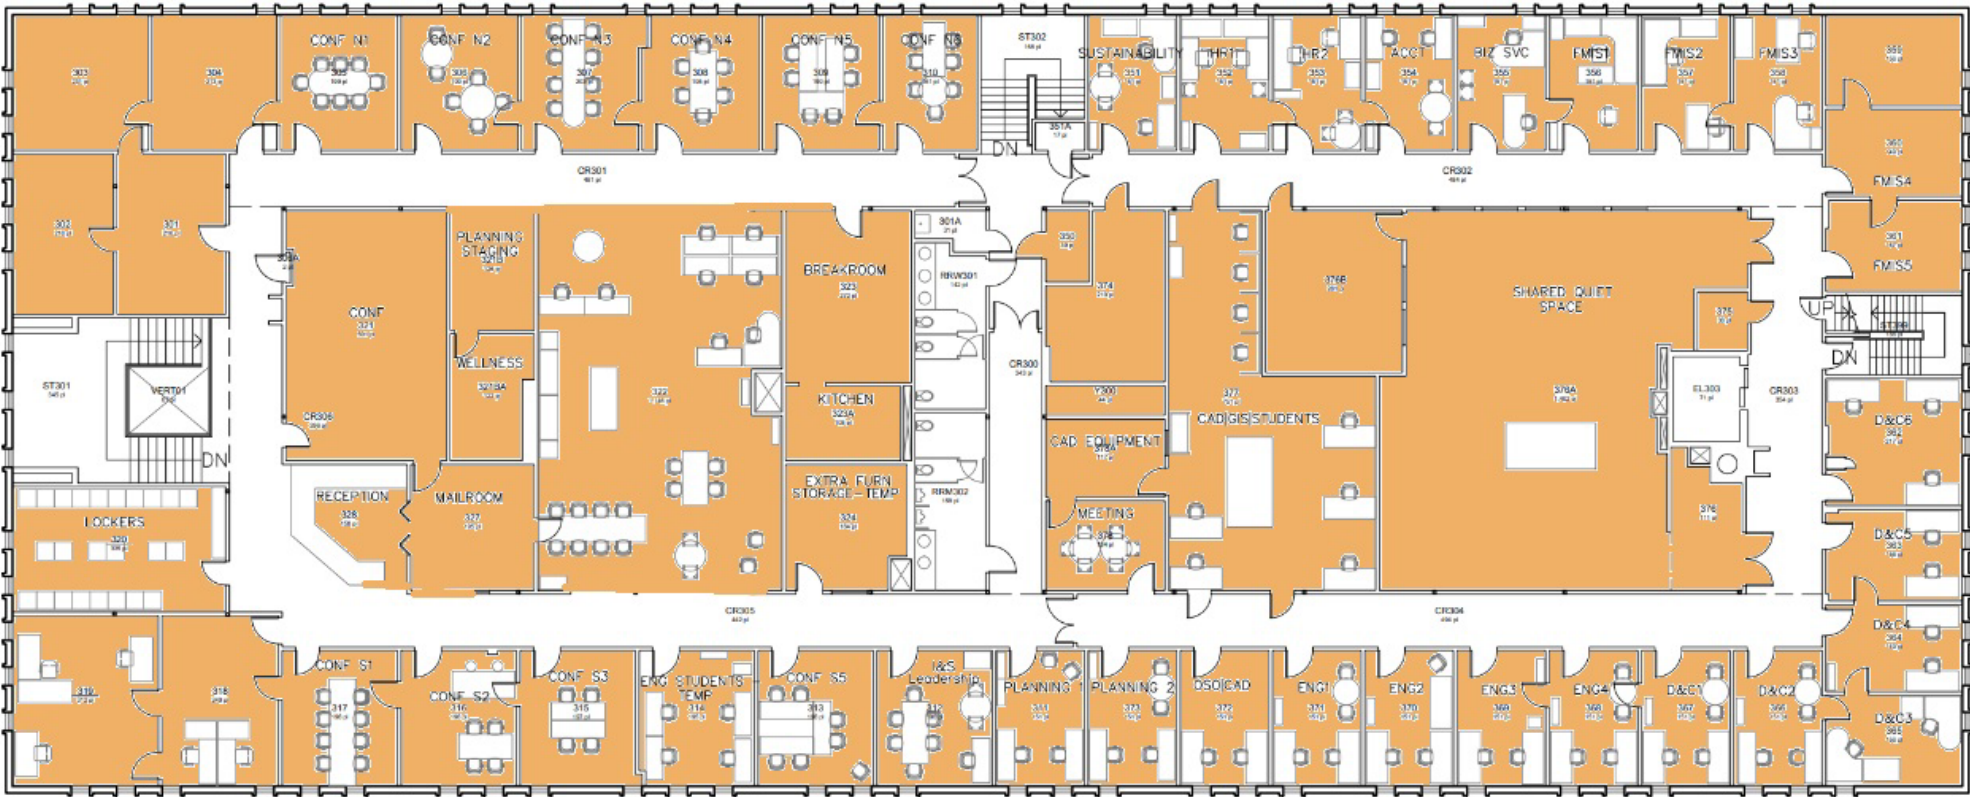

RESEARCH LAB NO 2

PD&C - expires 6/30/29



P: 303-492-2511
E: PACAD@COLORADO.EDU
NOTE: THIS DRAWING IS NOT TO BE USED
FOR ANY PURPOSES NOT INTENDED BY THE ARCHITECT